


PACIFIC
 PRE-ENGINEERED
 EL GRANDE

SECOND FLOOR PLAN


SCALE 1/4" = 1'-0"

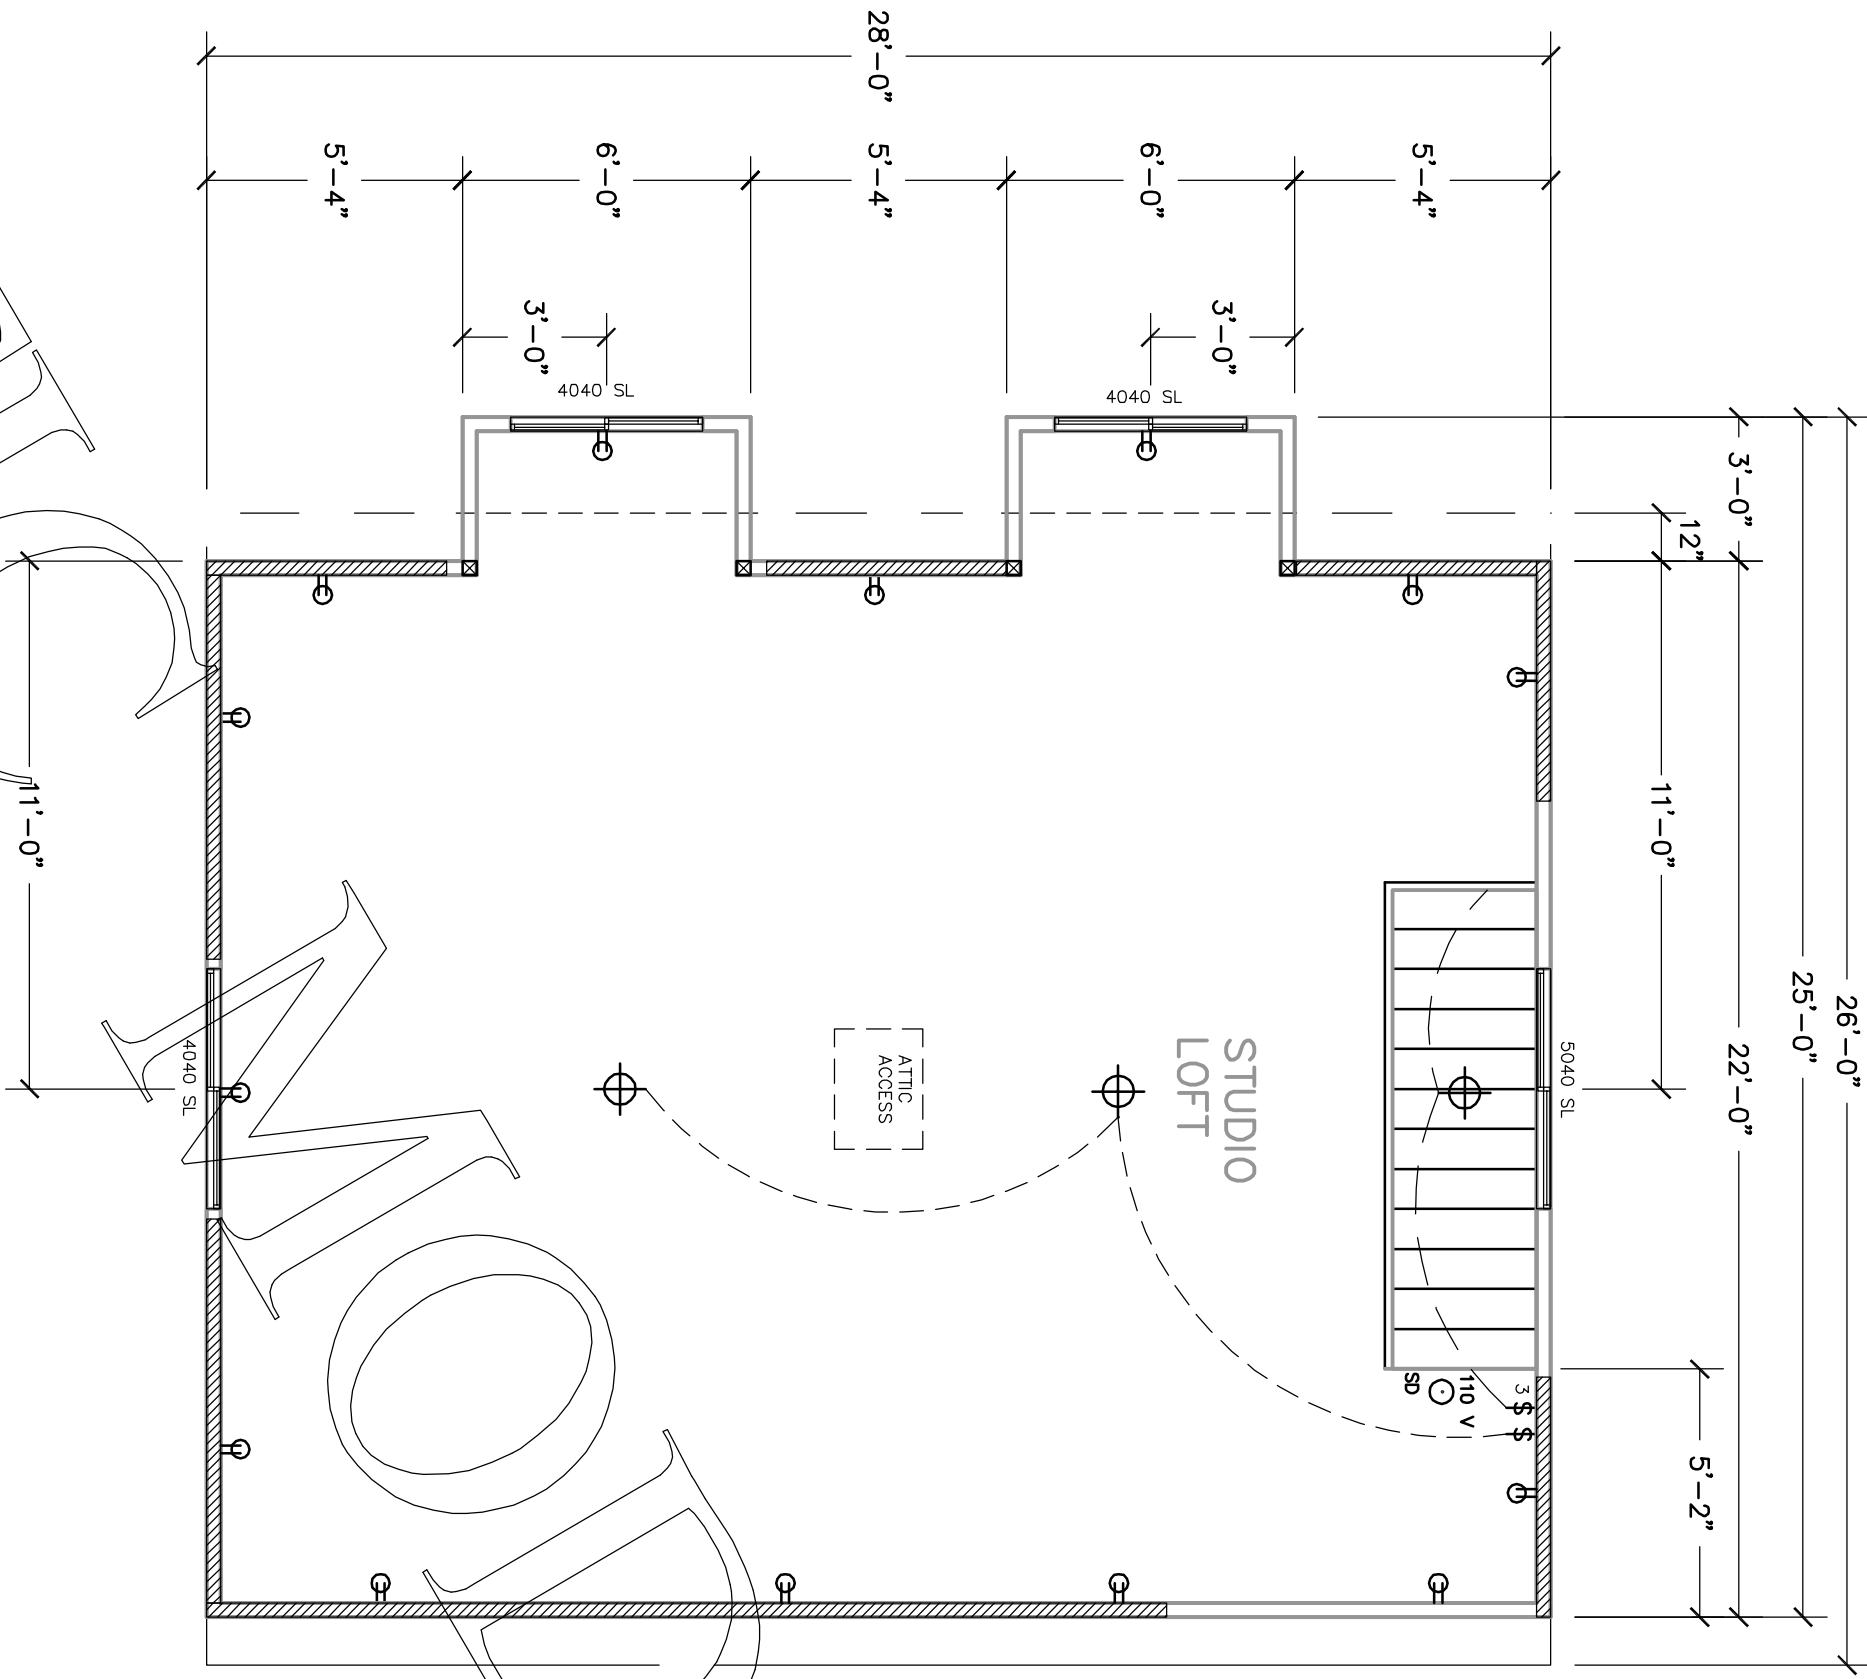

- LEGEND**
- ⚡ SWITCH
 - ⊕ RECEPTACLE
 - ⊕ LIGHT
 - ⊕ FAN LIGHT
 - ⊕ SMOKE DETECTOR
 - ⊕ HOSE BIB

FIRST FLOOR PLAN

SCALE 1/4" = 1'-0"

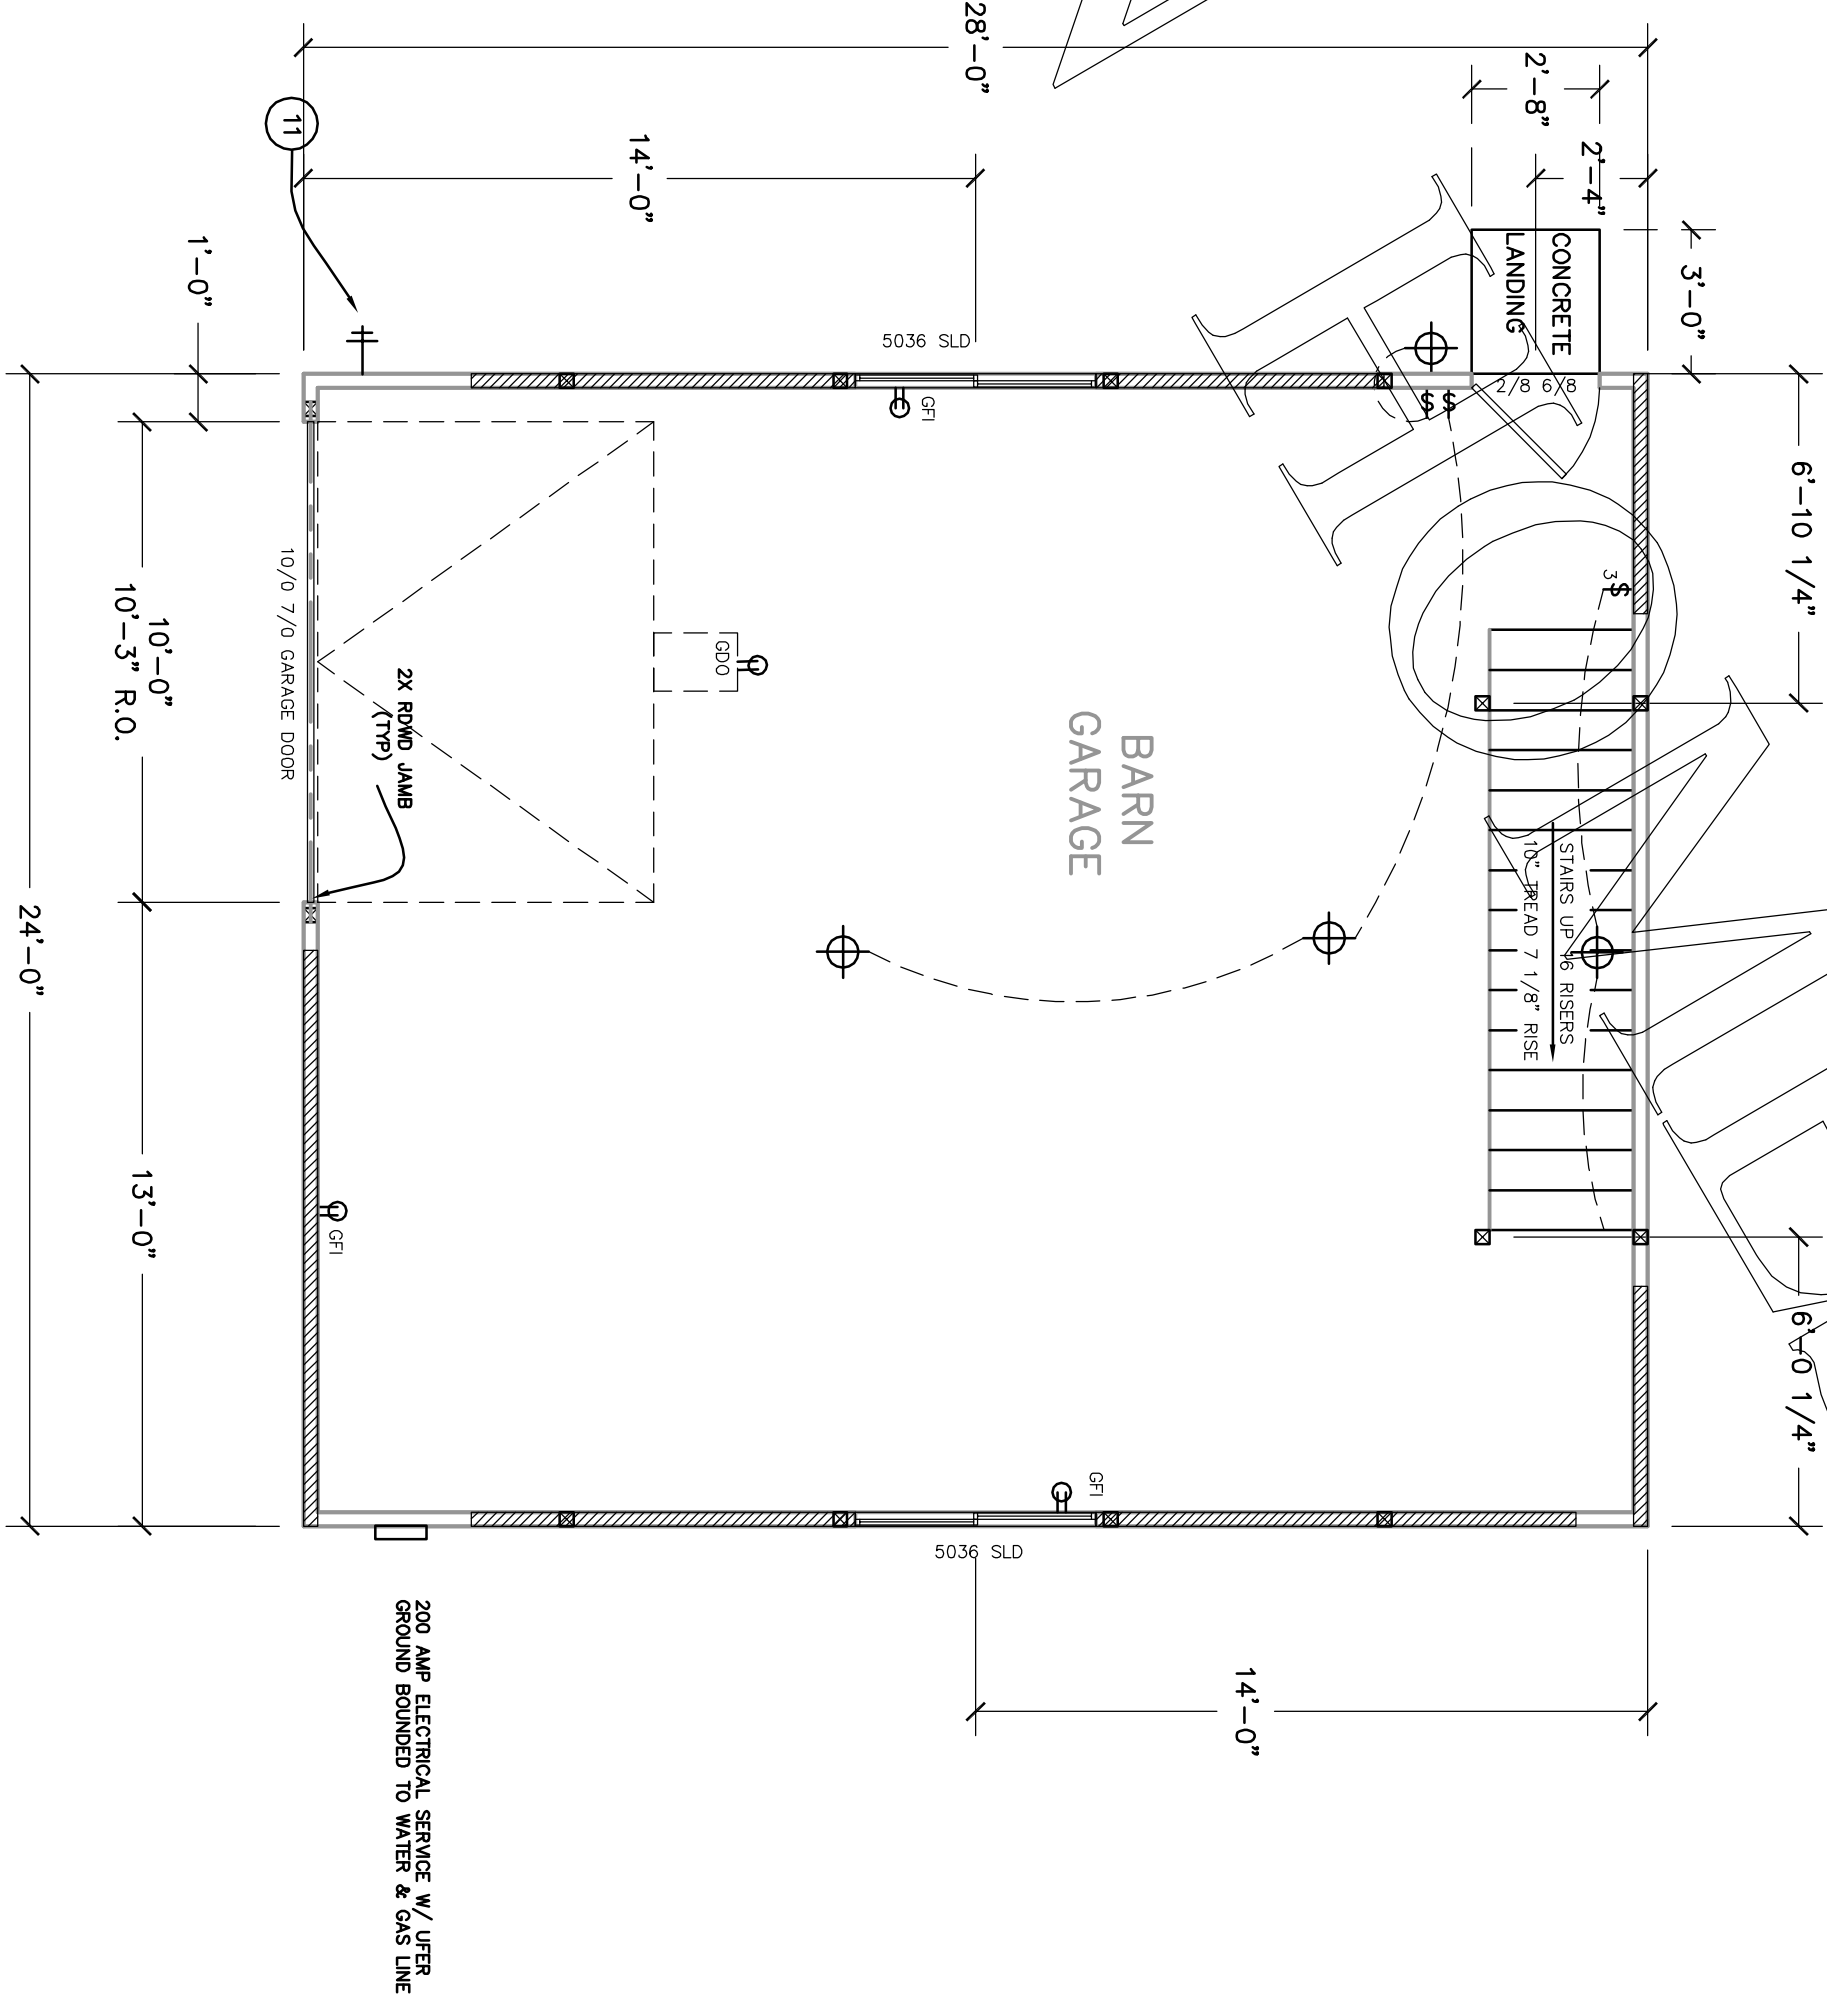

200 AMP ELECTRICAL SERVICE W/ LITER
 GROUND BOUNDED TO WATER & GAS LINE

INC.